


NOTES:

- 1.) REFER TO EVELYN AUDET LIGHTING DESIGN LIGHTING BILL OF MATERIALS FOR INFORMATION ON LIGHT FIXTURES.
- 2.) LIGHTING CONTROL KEY PADS TO BE LOCATED AT REAR HALL AND ENTRANCE TO KITCHEN AS INDICATED
- 3.) EMERGENCY EGRESS LIGHTING TO BE COORDINATED WITH ARCHITECT AS WELL AS LOCAL BUILDING CODES, ELECTRICAL CODES AND THE LOCAL AUTHORITY HAVING JURISDICTION.

REVISION _____ DATE _____
CONSULTANT _____

ARCHITECTS _____

Linberg & Simmons Ltd.

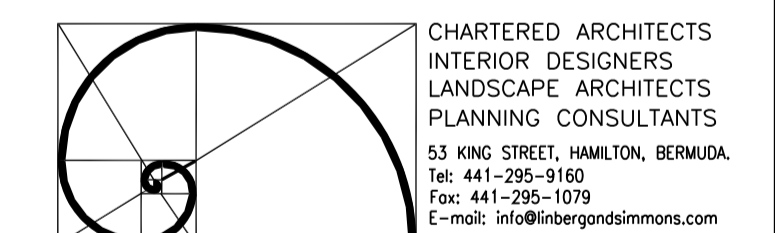

CHARTERED ARCHITECTS
INTERIOR DESIGNERS
LANDSCAPE ARCHITECTS
PLANNING CONSULTANTS
53 KING STREET, HAMILTON, BERMUDA
Tel: 441-295-9160
Fax: 441-295-1079
E-mail: info@linbergsimmons.com

CLIENT
Seon Ltd.

26 Victoria St.
Hamilton

PROJECT
**Seon Place Ltd.
Bistro**

139-143 Front St.
Hamilton, HM19

DRAWING TITLE
LIGHTING PLAN

**■ EVELYN AUDET ■
LIGHTING DESIGN**

SCALE	DRAWN	FIRST ISSUE
1/4" = 1'-0"	EALD	08/22/10
ISSUE	DATE	
		12/09/10
JOB	DRAWING	REVISION
ID614	EL-01	2